



LEGEND

 
PC	TLR A1	DESK TOP STAND-UP TELLER P.C.
PC	PC A1	DESK TOP SIT-DOWN RETAIL P.C.
PCPN	PCPN	TELLER PRINTER
PCPN	PCPN RETAIL	RETAIL PRINTER
PCPN LAP TOP	RETAIL LAN	RETAIL LAPTOP
PC	LPC	LEARNING PC TERMINAL
PCPN LAN	LAN	L.A.N. ATTACHED PRINTER
M.F.D.	MFD	MULTI-FUNCTION DEVICE SALES OR SERVICE
TM	A1	AUTOMATED TELLER MACHINE

☒	SYSTEM UNIT
☒	SYSTEM UNIT UNDER DESK
☐	POWER PANEL

- | | |
|---|--|
|  | 1G. SIMPLEX RECEPTACLE (TWISTLOCK)
(# INDICATES CIRCUIT NUMBER) |
|  | 1G. SIMPLEX RECEPTACLE
(# INDICATES CIRCUIT NUMBER) |
|  | 1G. DUPLEX RECEPTACLE
(# INDICATES CIRCUIT NUMBER) |
|  | 1G. QUAD RECEPTACLE
(# INDICATES CIRCUIT NUMBER) |
|  | DUPLEX RECEPTACLE (NON 1G.)
(# INDICATES CIRCUIT NUMBER) |
|  | DATA/VOICE OUTLET
(# INDICATES OUTLET NUMBER) |
|  | DATA OUTLET
(# INDICATES OUTLET NUMBER) |
|  | VOICE OUTLET
(# INDICATES OUTLET NUMBER) |



19" COMMUNICATIONS RELAY RACK c/w
4" VERTICAL MANAGEMENT TROUGHS ON
EACH SIDE



FILE SERVER CABINET
(FH = FULL HEIGHT, LH = LOW HEIGHT)

18" X 18" ZONE BOX

JUNCTION BOX (SIZE AS INDICATED)

8" X 8" BRANCH BOX

OP NETPOP SERVICE LOCAL

CONDUIT/EMT (R/UN TURNED UP


CONDUIT/EMT (RUN TURNED DO

DATA CONDUIT

POWER CONDUIT

WORKSTATION NOTES:

1. CABLING - RE-CABLE EACH WORKSTATION, TELLER AND PRINTER WITH (1) CAT5E CABLE DROP IF EXISTING CABLE DOES NOT PASS CAT5E TEST.

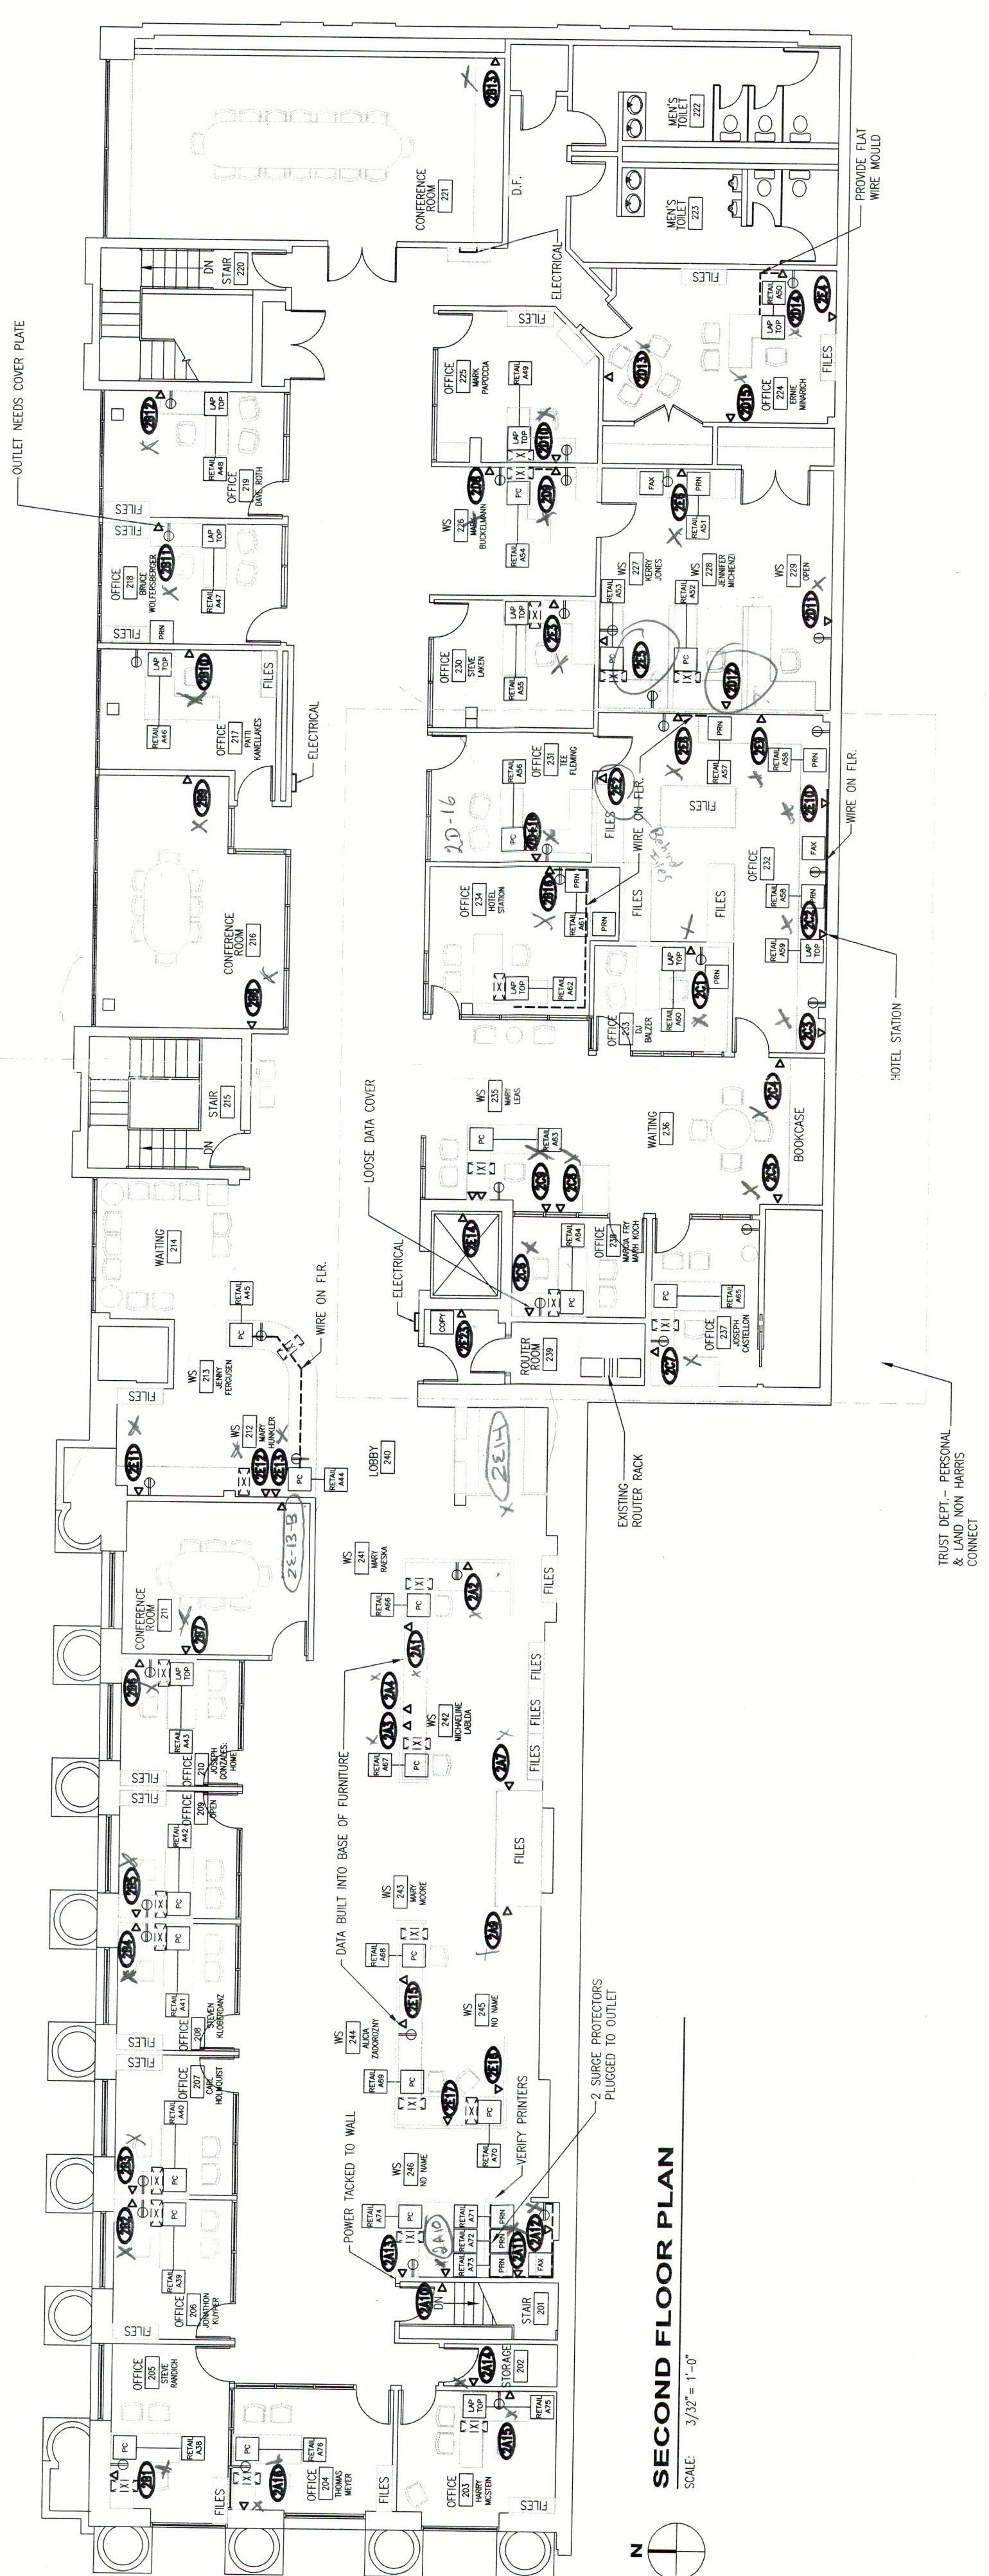

SCALE: $\frac{3}{32}'' = 1'-0''$

No.	Description	Date	By
12	AS BUILT	02-24-06	LDB
11	3 ISSUED FOR CONSTRUCTION	02-24-06	RAC
10	2 PRELIMINARY	01-14-06	FJD
9	1 BULKHEAD APPROVAL	01-14-06	FJD
8			
7			
6			
5			
4	AS BUILT	02-24-06	LDB
3	3 ISSUED FOR CONSTRUCTION	02-24-06	RAC
2	1 BULKHEAD APPROVAL	01-14-06	FJD
1	PRELIMINARY	01-14-06	FJD

The Contractor shall check and verify all dimensions and quantities with the Designer before commencing work. All prints and specifications are the property of the BANK OF MONTREAL and must be returned to the Designer upon completion of the project. DO NOT SCALE THIS DRAWING.

Orientation



CO Financial Group
Technology and Solutions
Corporate Real Estate
Facilities Engineering

CHRIS BANK JOLIET
N. CHICAGO STREET
ET, IL 60432

ERIS CONNECT PROGRAM
SECOND FLOOR PLAN

Drawn By:	EJD
-----------	-----

No.:	" = 1'-0"	Date:	12-12-05
No.:		Hardware	Pic No.:

No.:	090-019
	272-HC